

**SINGLE LINE DIAGRAM FOR THE POWER EVACUATION FROM THE NEW PV POWER PLANT**

NOTES

REVISIONS, ADDITIONS & ALTERATIONS

NO	DATE	DESCRIPTION	BY

CONSULTANTS


CLIENT

**PROJECT**  
 PROPOSED NESCOM HYBRID  
 SOLAR PV POWER PLANT  
 WITH BESS

DRAWING NAME

DRAWING NAME

PROJECT NO	A201		
	A201/BF/L1/24		
			DATE
			DATE
REVISION NO	0	SCALE 1:100@A1	

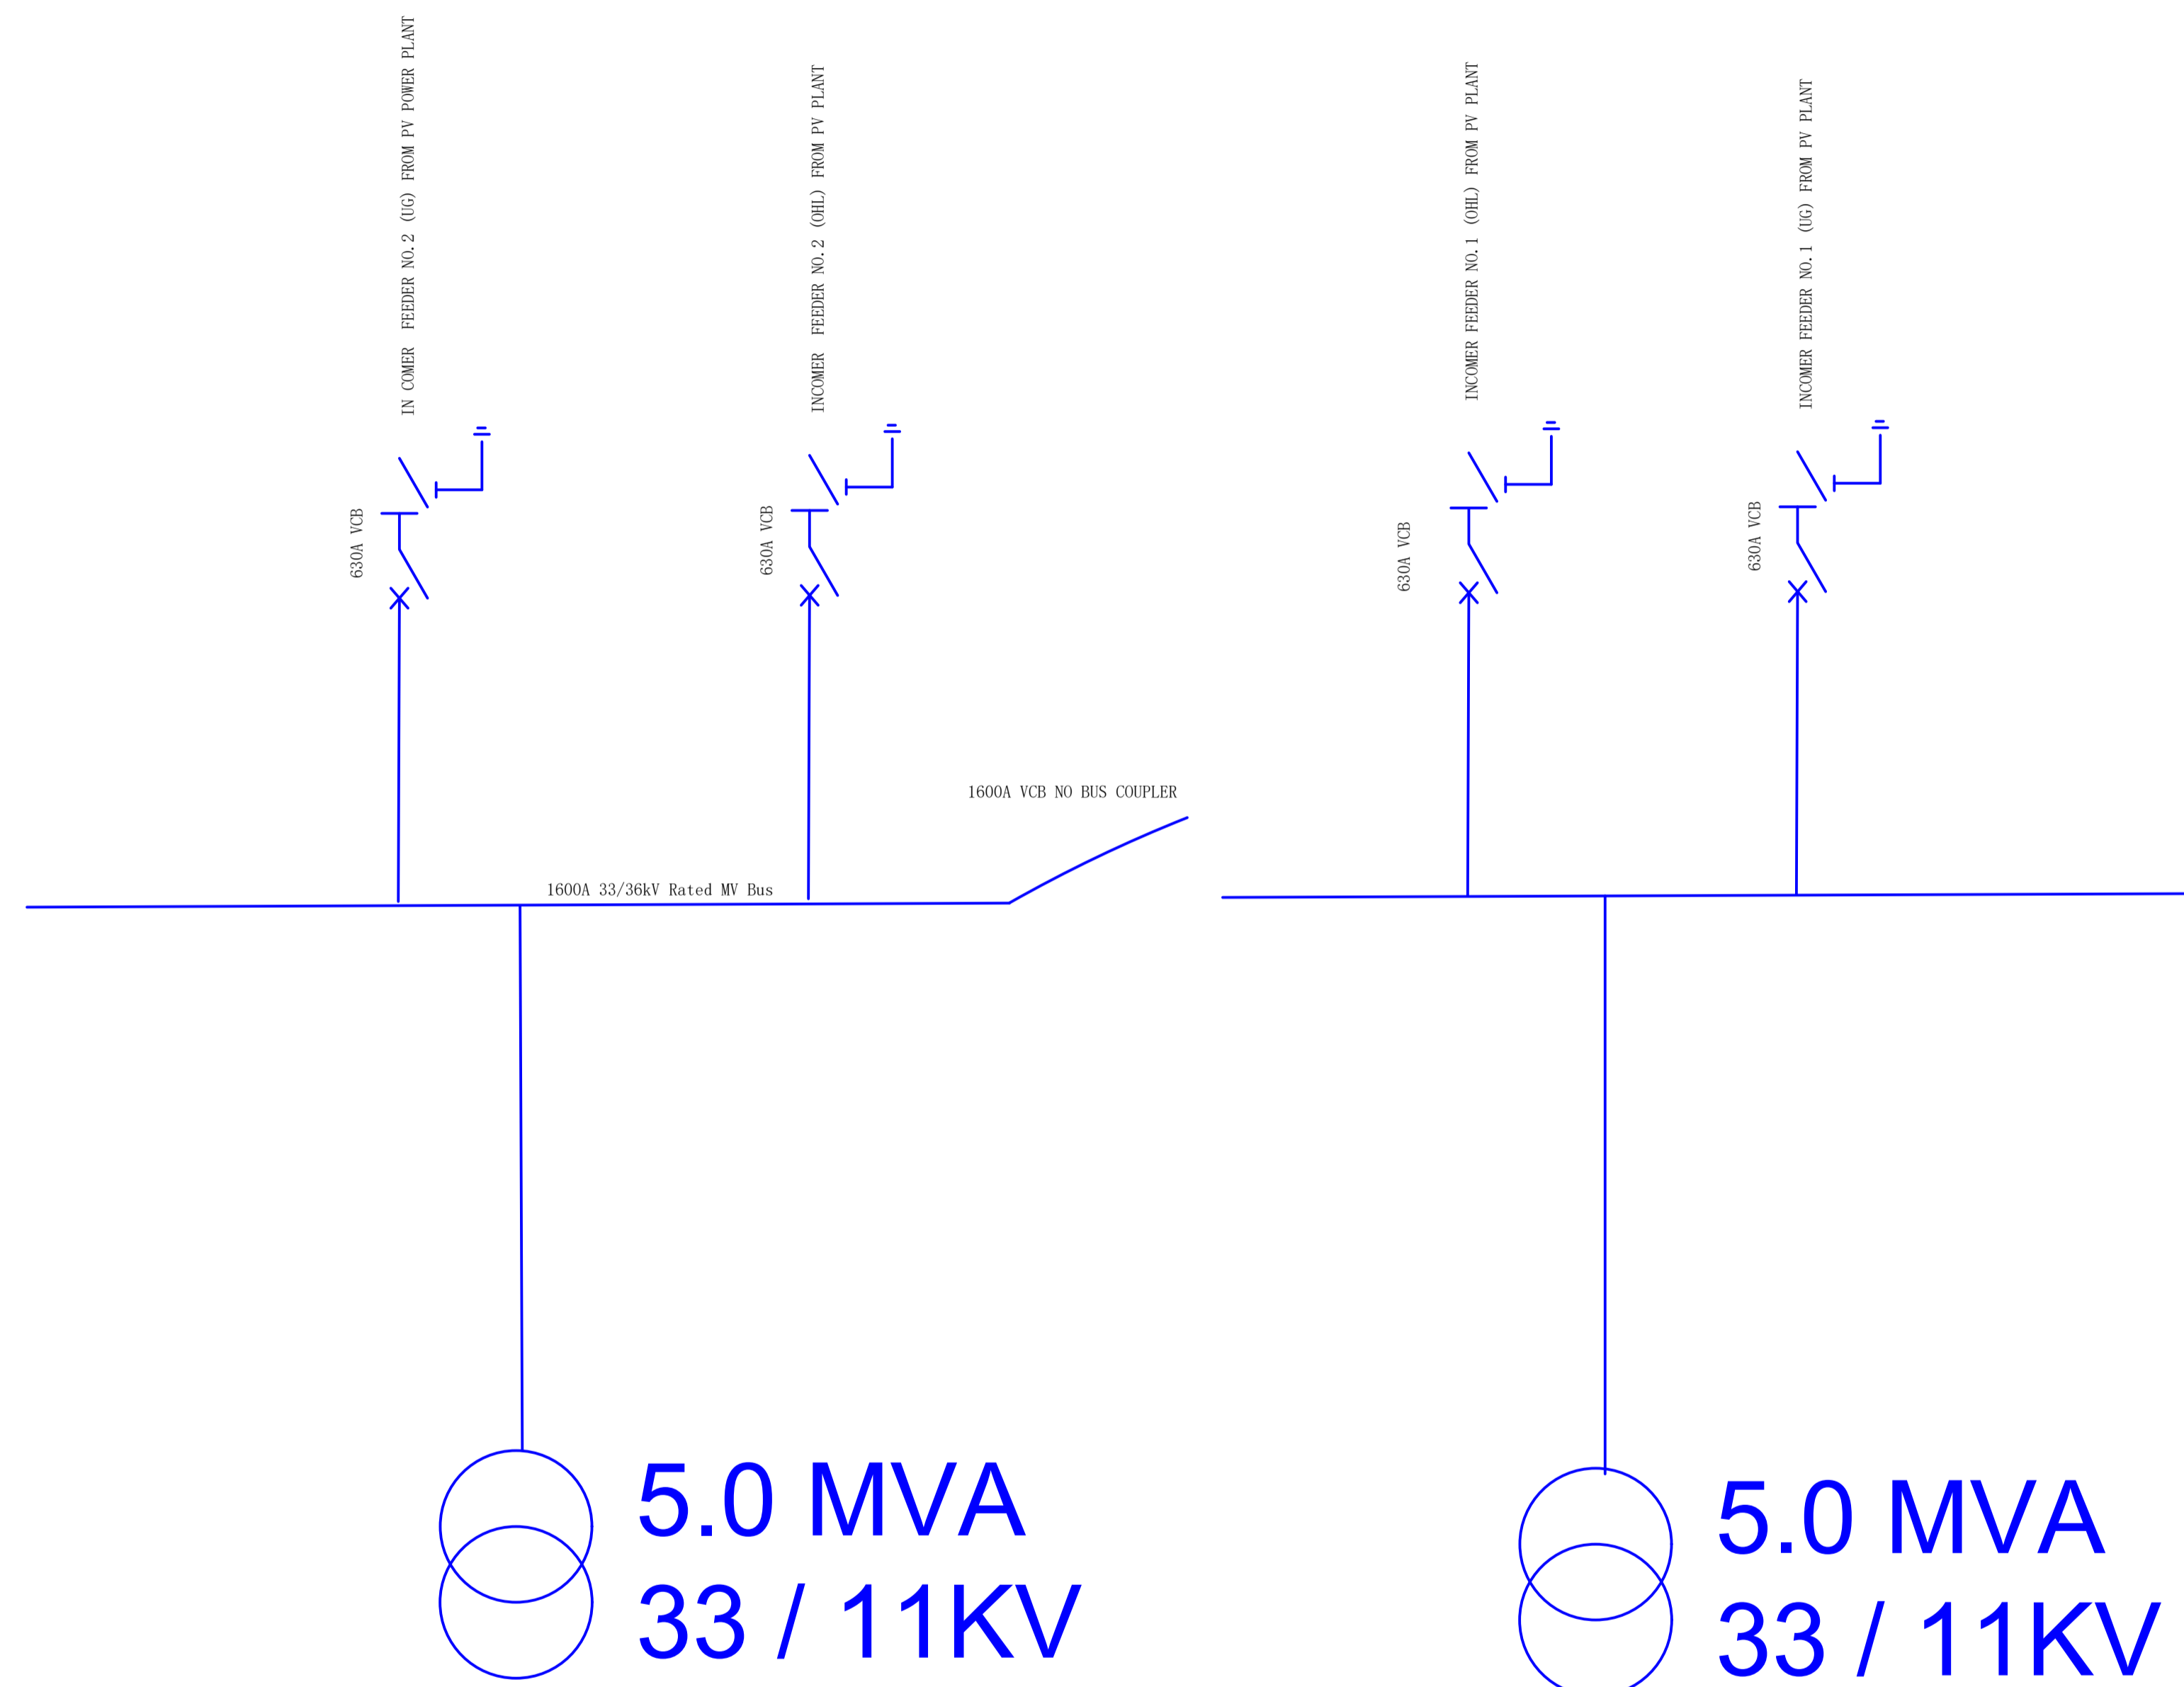

SINGLE LINE DIAGRAM FOR DISTRIBUTION SUBSTATION LOCATED 9.0KM FROM PV POWER PLANT

NOTES

REVISIONS, ADDITIONS & ALTERATIONS

NO	DATE	DESCRIPTION	BY

CONSULTANTS

CLIENT

PROJECT  
 PROPOSED NESCOM  
 DISTRIBUTION SUBSTATION

DRAWING NAME

DRAWING NAME

PROJECT NO	A201		
	A201/BF/L1/24		
		DATE	
		DATE	
REVISION NO	0	SCALE 1:100@A1	