


PROPOSED DHUSMAREEB 500kWp SOLAR PV PLANT & 1000KWH BESS SLD

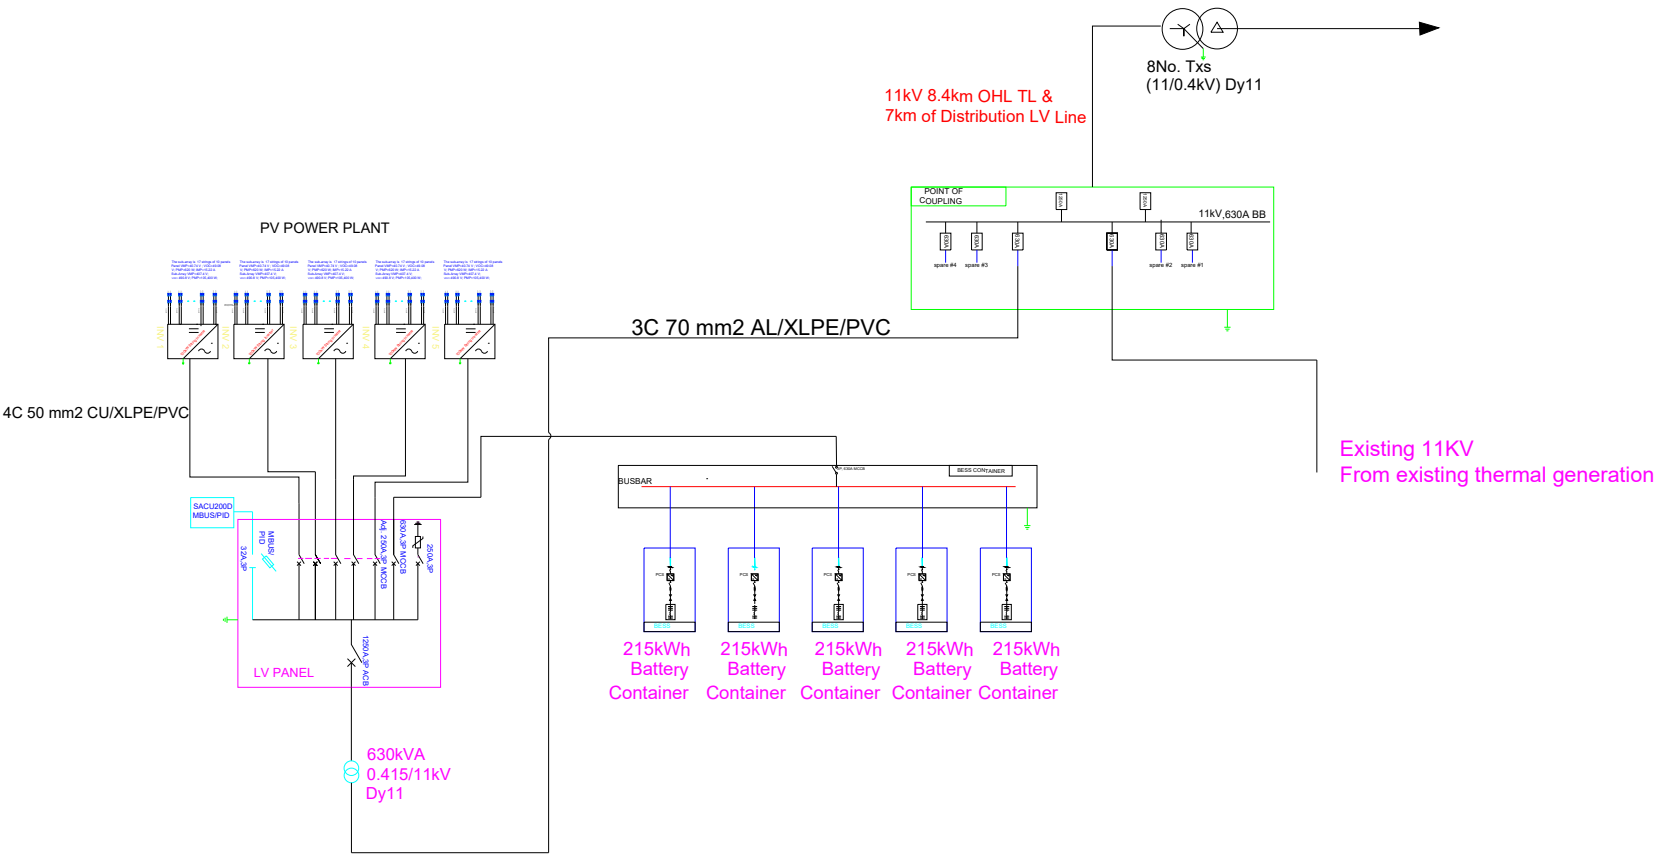

NOTES		

REVISIONS, ADDITIONS & ALTERATIONS		
NO	DATE	DESCRIPTION



PROJECT
PROPOSED HYBRID SOLAR
PV POWER PLANT WITH
BESS

DRAWING NAME
MAIN SCHEMATIC LAYOUT

DRAWING NAME
MAIN SCHEMATIC LAYOUT

PROJECT NO	
DRAWING NO	
DRAWN BY	
DESIGNED BY	
REVISION NO	0

SIGN	DATE

SCALE	1:1000