


PROPOSED EYL 450kWp SOLAR PV PLANT & 750kWh ESS SINGLE LINE DIAGRAM

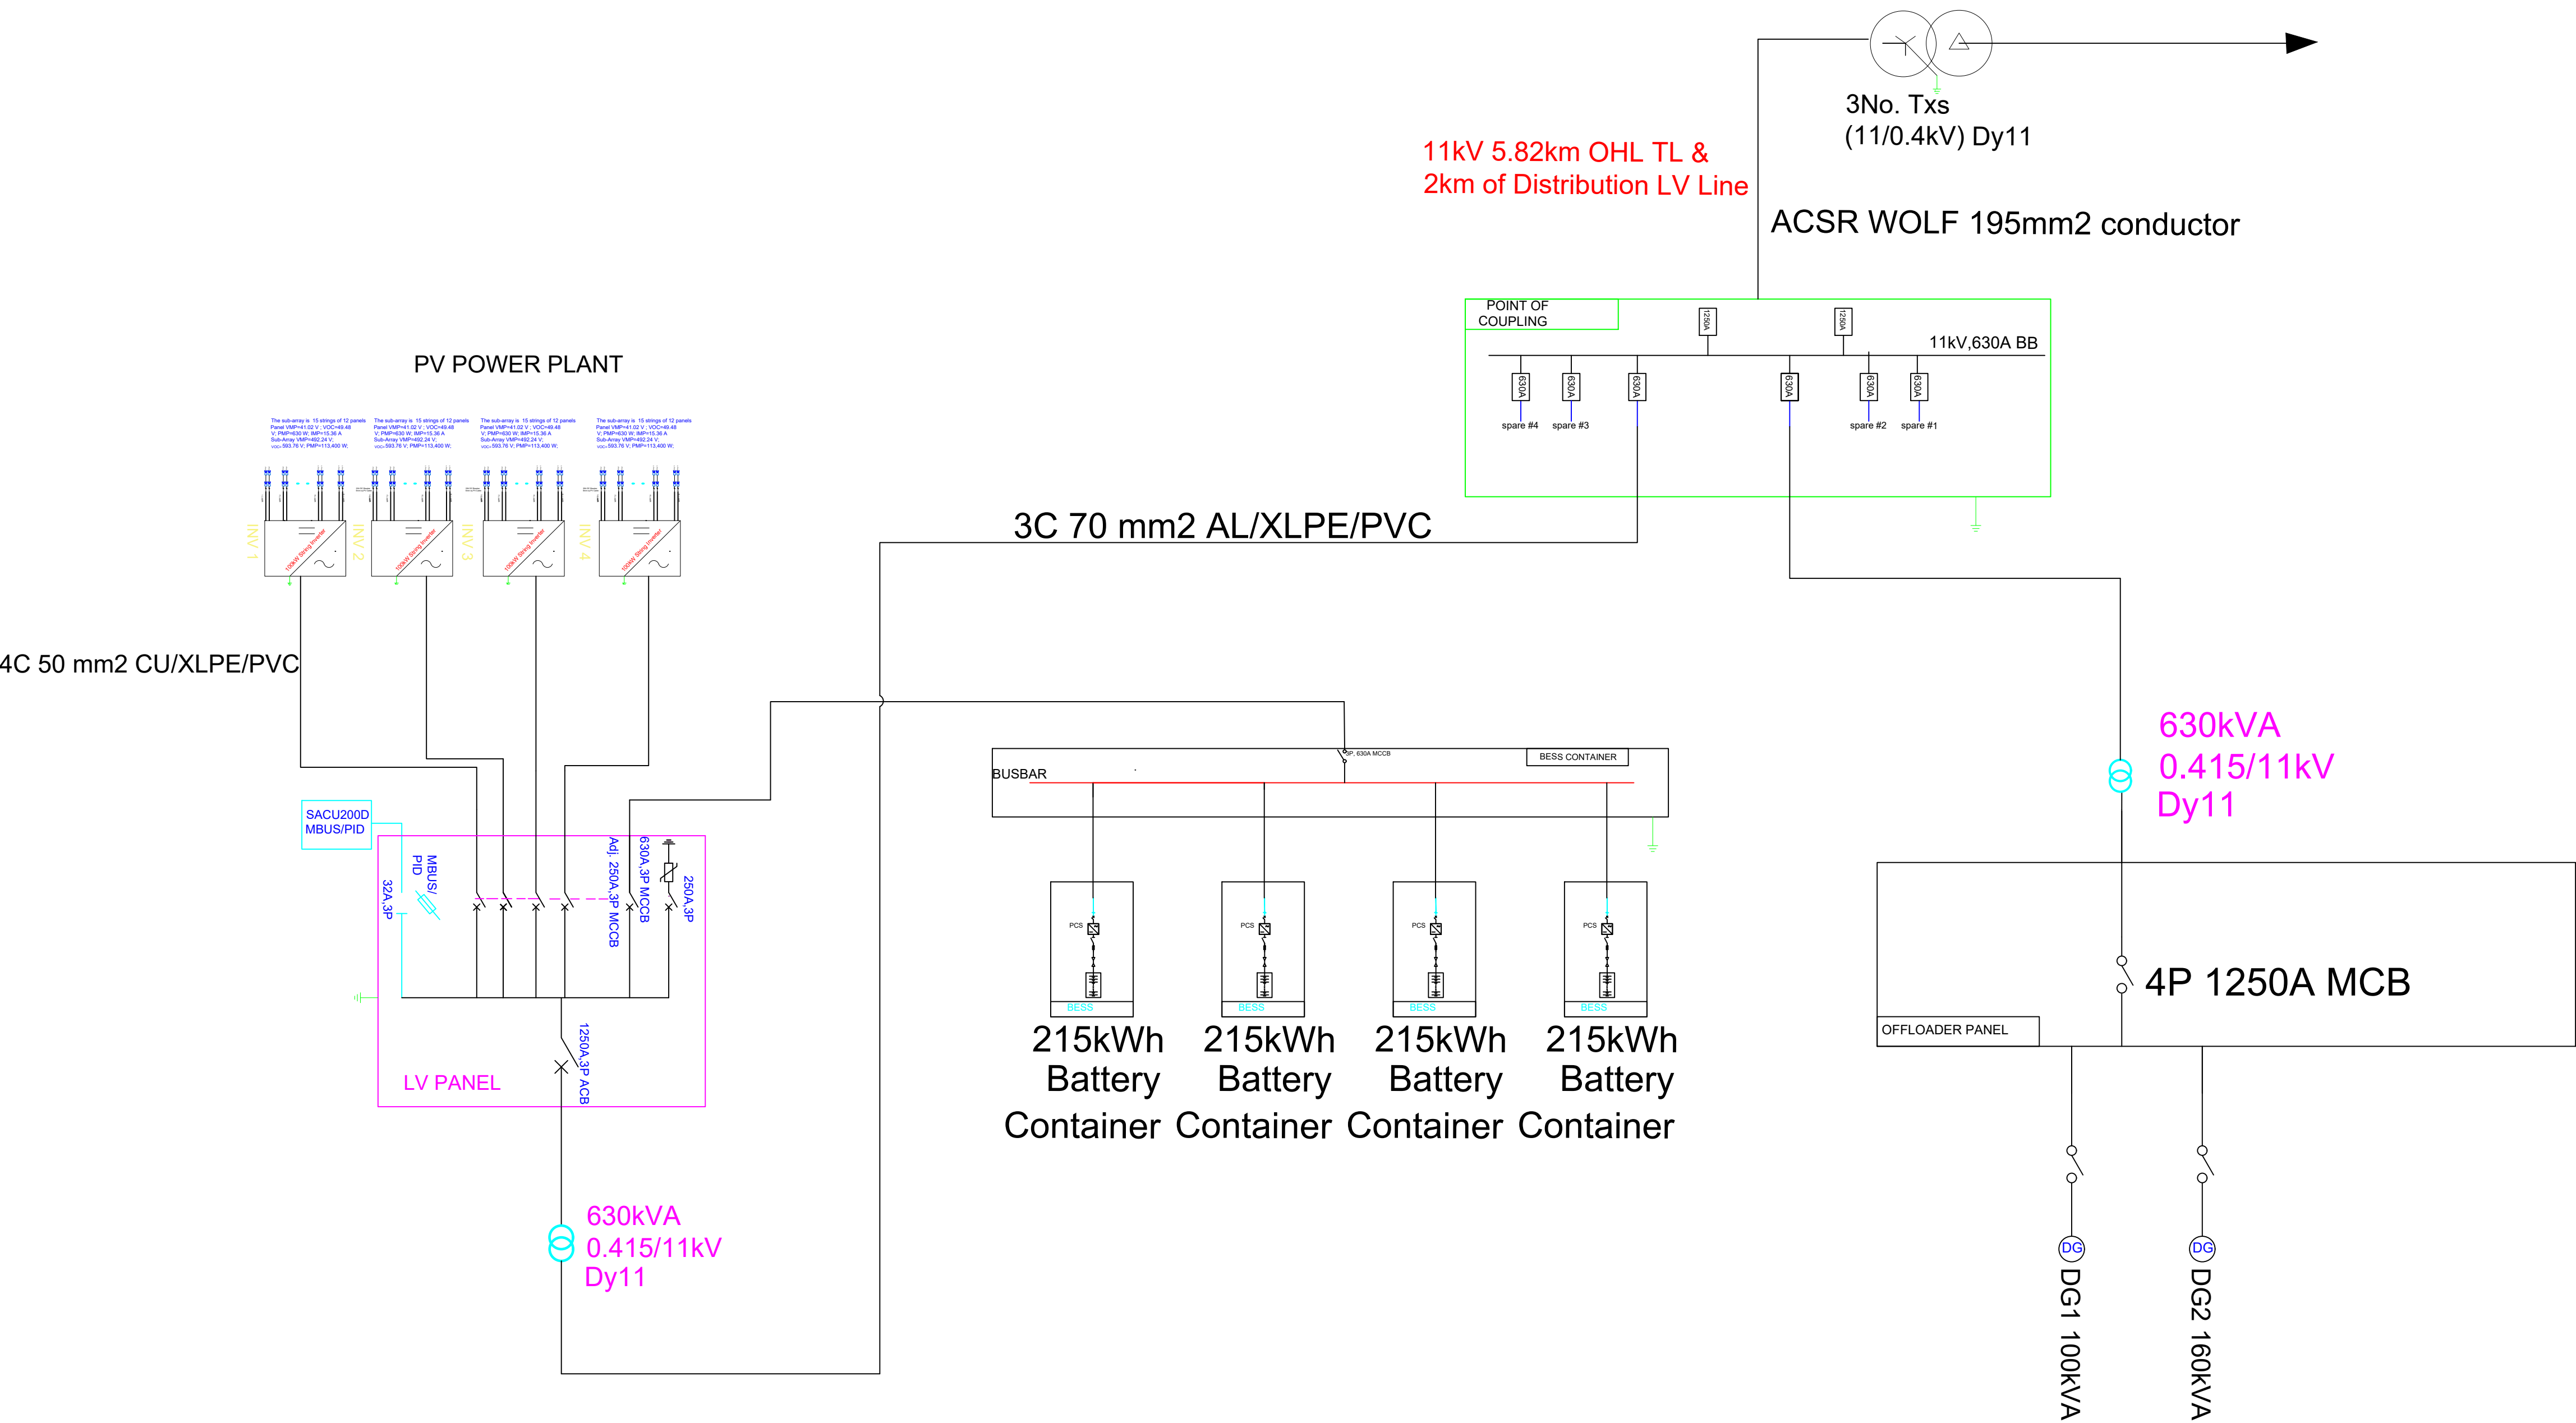

- NOTES
1. THIS DRAWING IS TO BE READ IN CONJUNCTION WITH ALL OTHER DISCIPLINES DRAWINGS SCHEDULES AND SPECIFICATIONS LEGENDS AND STANDARDS DETAILS.
 2. THIS DRAWING IS COPYRIGHT AND SHALL NOT BE REPRODUCED WITHOUT PERMISSION.
 3. DIMENSIONS GOVERN ON ALL DRAWINGS AND DETAILS SHOULD ANY DISCREPANCIES BE FOUND WITH THIS DRAWING AND ANY ASSOCIATED DRAWINGS OR SPECIFICATIONS THIS SHOULD BE BROUGHT TO THE ATTENTION OF THE M&E BUILDING SERVICES CONSULTANT IMMEDIATELY.
 4. UNLESS OTHERWISE STATED ALL DIMENSIONS ARE IN MILLIMETRES.
 5. DO NOT SCALE FROM THIS DRAWING.
 6. DIMENSIONS TO BE CHECKED ON SITE BEFORE ANY IS PUT IN HAND OR PREFABRICATED.
 7. THIS DRAWING SHOULD ONLY BE USED FOR THE SPECIFIC SERVICES INTENDED.
 8. THIS DRAWING SHOWS THE DESIGN INTENT ONLY. THE CONTRACTOR SHALL BE RESPONSIBLE FOR THE FULL CO-ORDINATION OF THE SERVICES INDICATED ON THIS AND ALL OTHER SERVICES DRAWINGS.
 9. FINAL ACCESS AND SETTING OUT OF SERVICES SHALL BE AGREED BETWEEN THE ARCHITECT AND THE CONTRACTOR.
 10. THE PROJECT NOTES ARE TO BE READ IN CONJUNCTION WITH ALL RELEVANT TECHNICAL SPECIFICATIONS.

REVISIONS, ADDITIONS & ALTERATIONS			
NO	DATE	DESCRIPTION	BY



PROJECT
PROPOSED HYBRID SOLAR
PV POWER PLANT WITH
BESS-EYL

DRAWING NAME
MAIN SCHEMATIC LAYOUT

DRAWING NAME
MAIN SCHEMATIC LAYOUT

PROJECT NO	
DRAWING NO	
DRAWN BY	SIGN DATE
DESIGNED BY	SIGN DATE
REVISION NO	0 SCALE 1:100@A1