


PROPOSED JOWHAR 500kWp SOLAR PV PLANT & 1000KWH BESS SLD

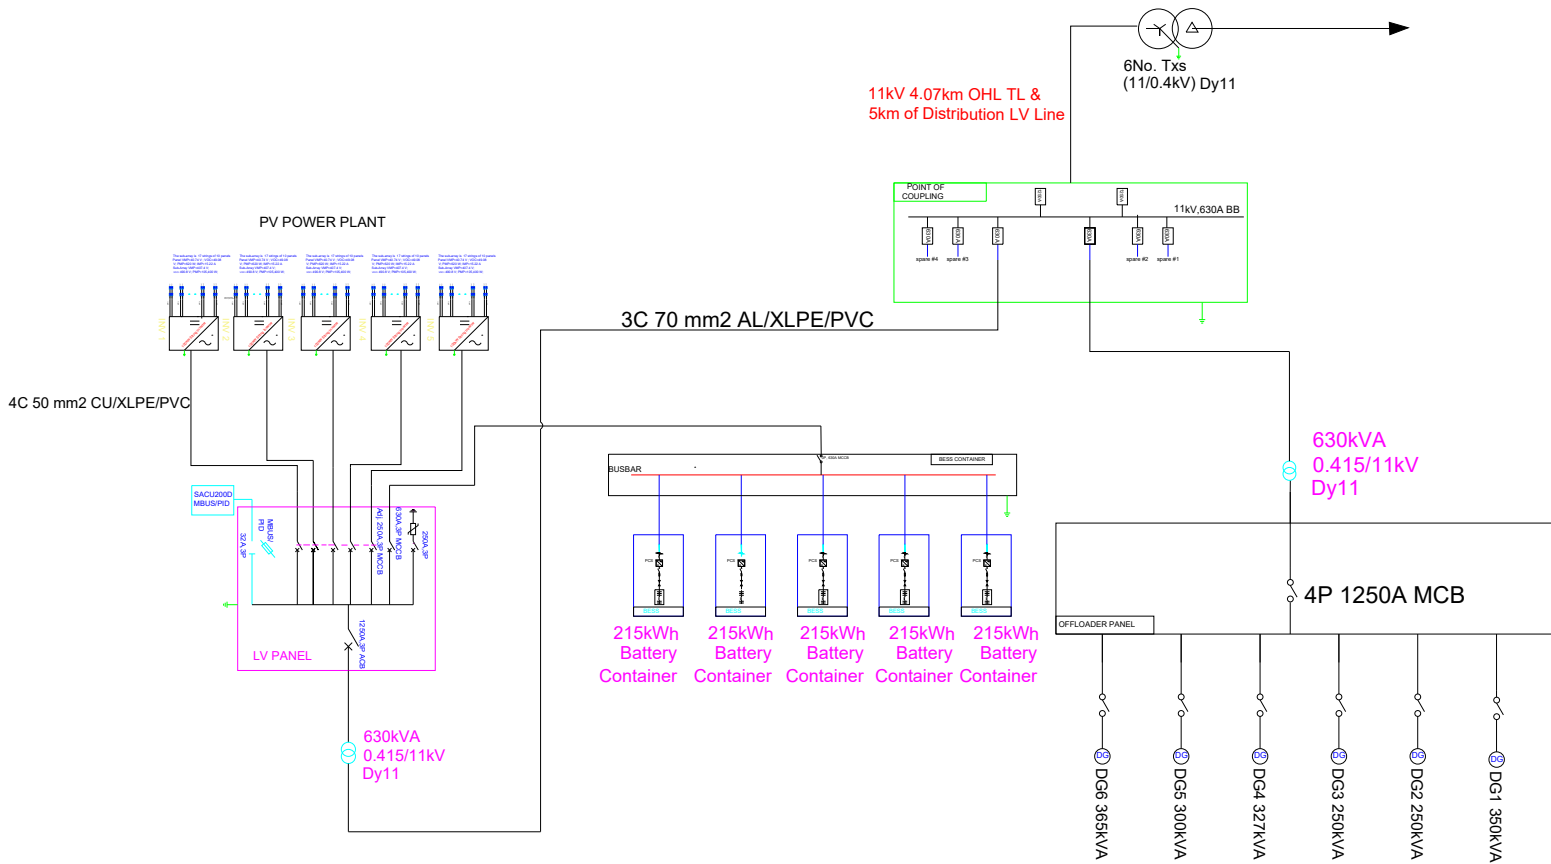

NOTES

[illegible]

CONSULTANTS

 **DELTA**
Engineering & Development Ltd

CLIENT	
--------	---

PROJECT
PROPOSED HYBRID SOLAR PV POWER PLANT WITH BESS

DRAWING NAME
MAIN SCHEMATIC LAYOUT
DRAWING NAME
MAIN SCHEMATIC LAYOUT

PROJECT NO					
DRAWING NO					
DRAWN BY	SIGN		DATE		
DESIGNED BY	SIGN		DATE		
REVISION NO	0	SCALE 1:100@A1			