


PROPOSED BARAWE 500kWp SOLAR PV PLANT & 1MWH ESS SINGLE LINE DIAGRAM

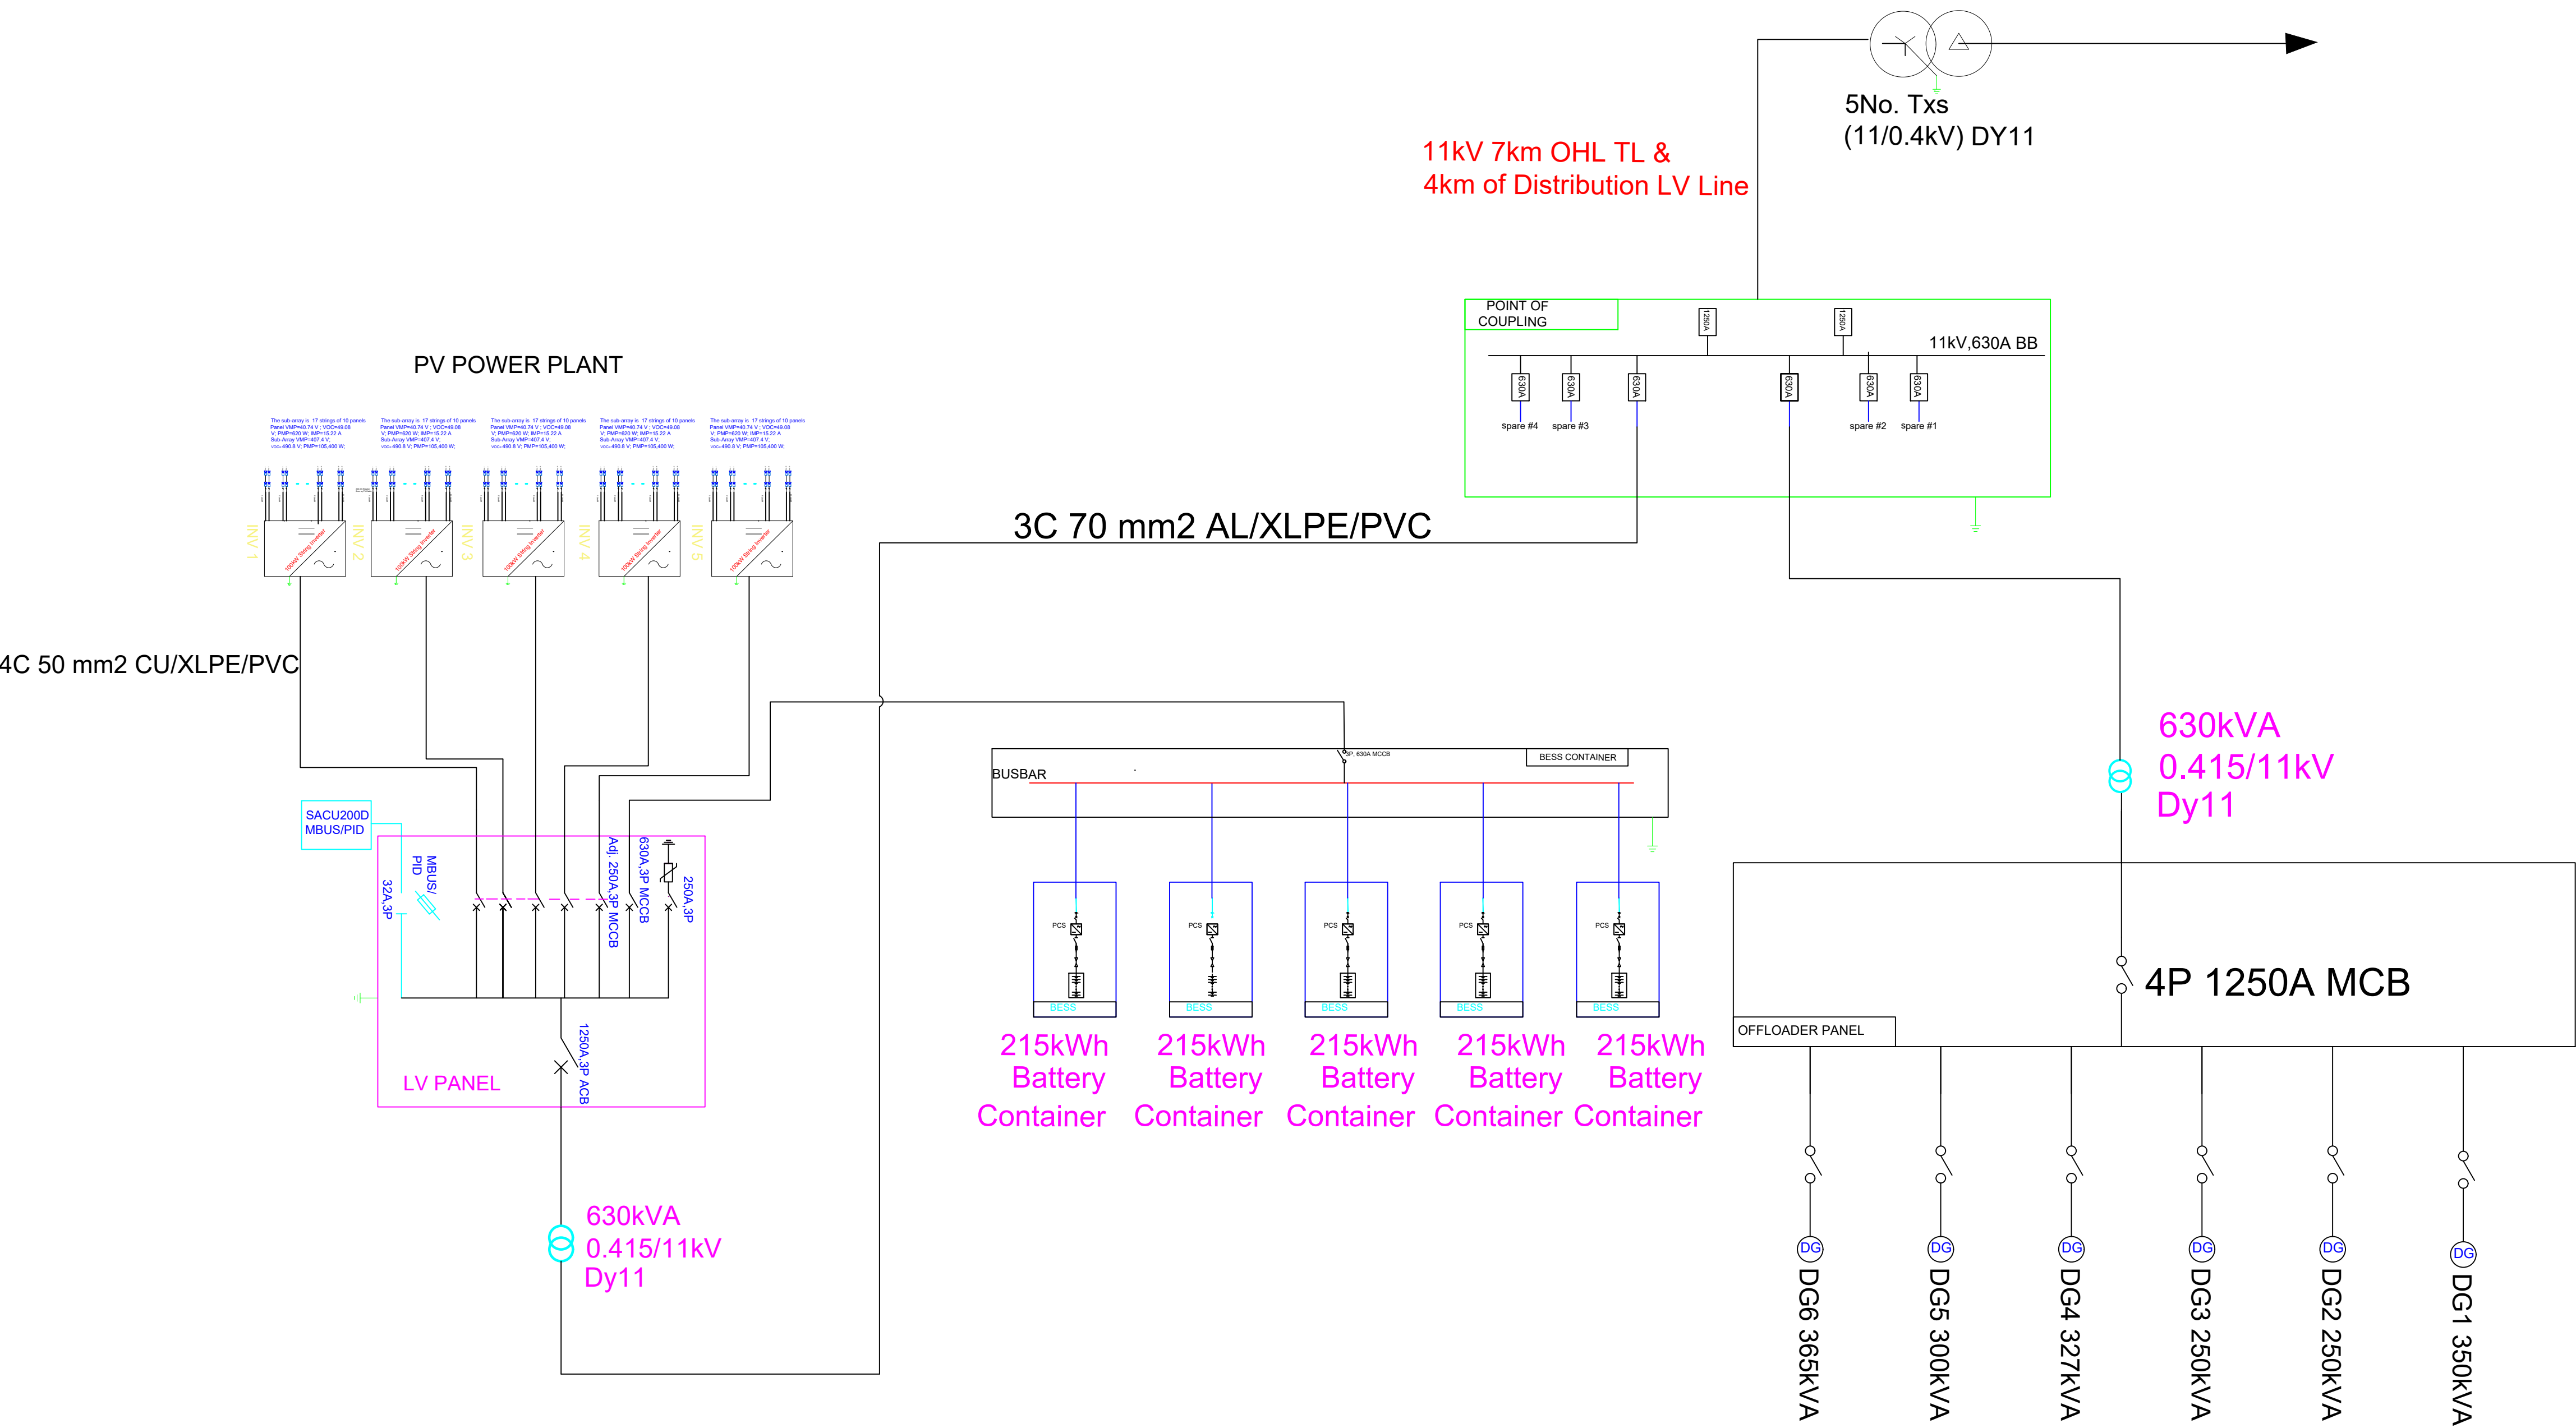

NOTES		

REVISIONS, ADDITIONS & ALTERATIONS			
NO	DATE	DESCRIPTION	BY

CONSULTANTS

CLIENT

PROJECT

PROPOSED HYBRID SOLAR PV POWER PLANT WITH BESS-BARAWA

DRAWING NAME

MAIN SCHEMATIC LAYOUT

DRAWING NAME

MAIN SCHEMATIC LAYOUT

PROJECT NO			
DRAWING NO			
DRAWN BY	SIGN	DATE	
DESIGNED BY	SIGN	DATE	
REVISION NO	0	SCALE 1:100@A1	